

**KEY:**

Emerg. Rd / Site Road	Steelshield Fence	Hera Fence	Stage Sighting
Toilet Block	Concession	First Aid Post	CCTV Camera
Emergency Exit Route	Drinking Water	Fire Hydrant	Water Pipe
Pedestrian Route	Floodlights (Indicative)	Festoon Lit Walkway	Route and Park Exit
Trackway Panels Are 3m Wide And Are Suitable For Carrying a 16.25 Tonne Fire Appliance.	Water	Entrance Route	

**SITE BOUNDARY**

Access to and from the coffee shop will be via the Walled Nursery Garden via the Grange Road.

**KEY CONTACTS**

Licence Compliance - Ange Goliger Tel: 086 0295820  
 Fire Safety Officer - David Slattery Tel: 087 9437787  
 Fire Safety Officer - Adrian Sutton Tel: 086 3940225

SCALE 1:1500 (@ A1)  
 DRAWING BY RICHARD WHITE  
 FOR MELVIN BENN AND FESTIVAL REPUBLIC

CONTACT: MELVIN BENN  
 THE FESTIVAL OFFICE  
 BORD GAIS ENERGY THEATRE  
 GRAND CANAL SQUARE  
 DOCKLANDS, DUBLIN 2

TEL (01) 6742476  
 GRIDLINES 50M X 50M

Rev.	Description	Date

**Michael Slattery Associates**  
 Fire Safety Engineers

23 Windsor Place  
 Lower Pembroke Place  
 Dublin 2, Ireland  
 Tel: +353(0)1 6752713  
 Fax: +353(0)1 6752247

Building Design & Construction  
 Fire Engineering  
 Event Safety & Management  
 Building Use Safety Management  
 Disabled Access Consultancy  
 Computer Modelling

PROJECT: LONGITUDE 2015  
 MARLAY PARK


TITLE: SITE PLAN

SCALE: 1:1500 @ A1    JOB No: 1510

DATE: 13.04.2015    DWG No: 1510-01

CHECKED BY:    Rev



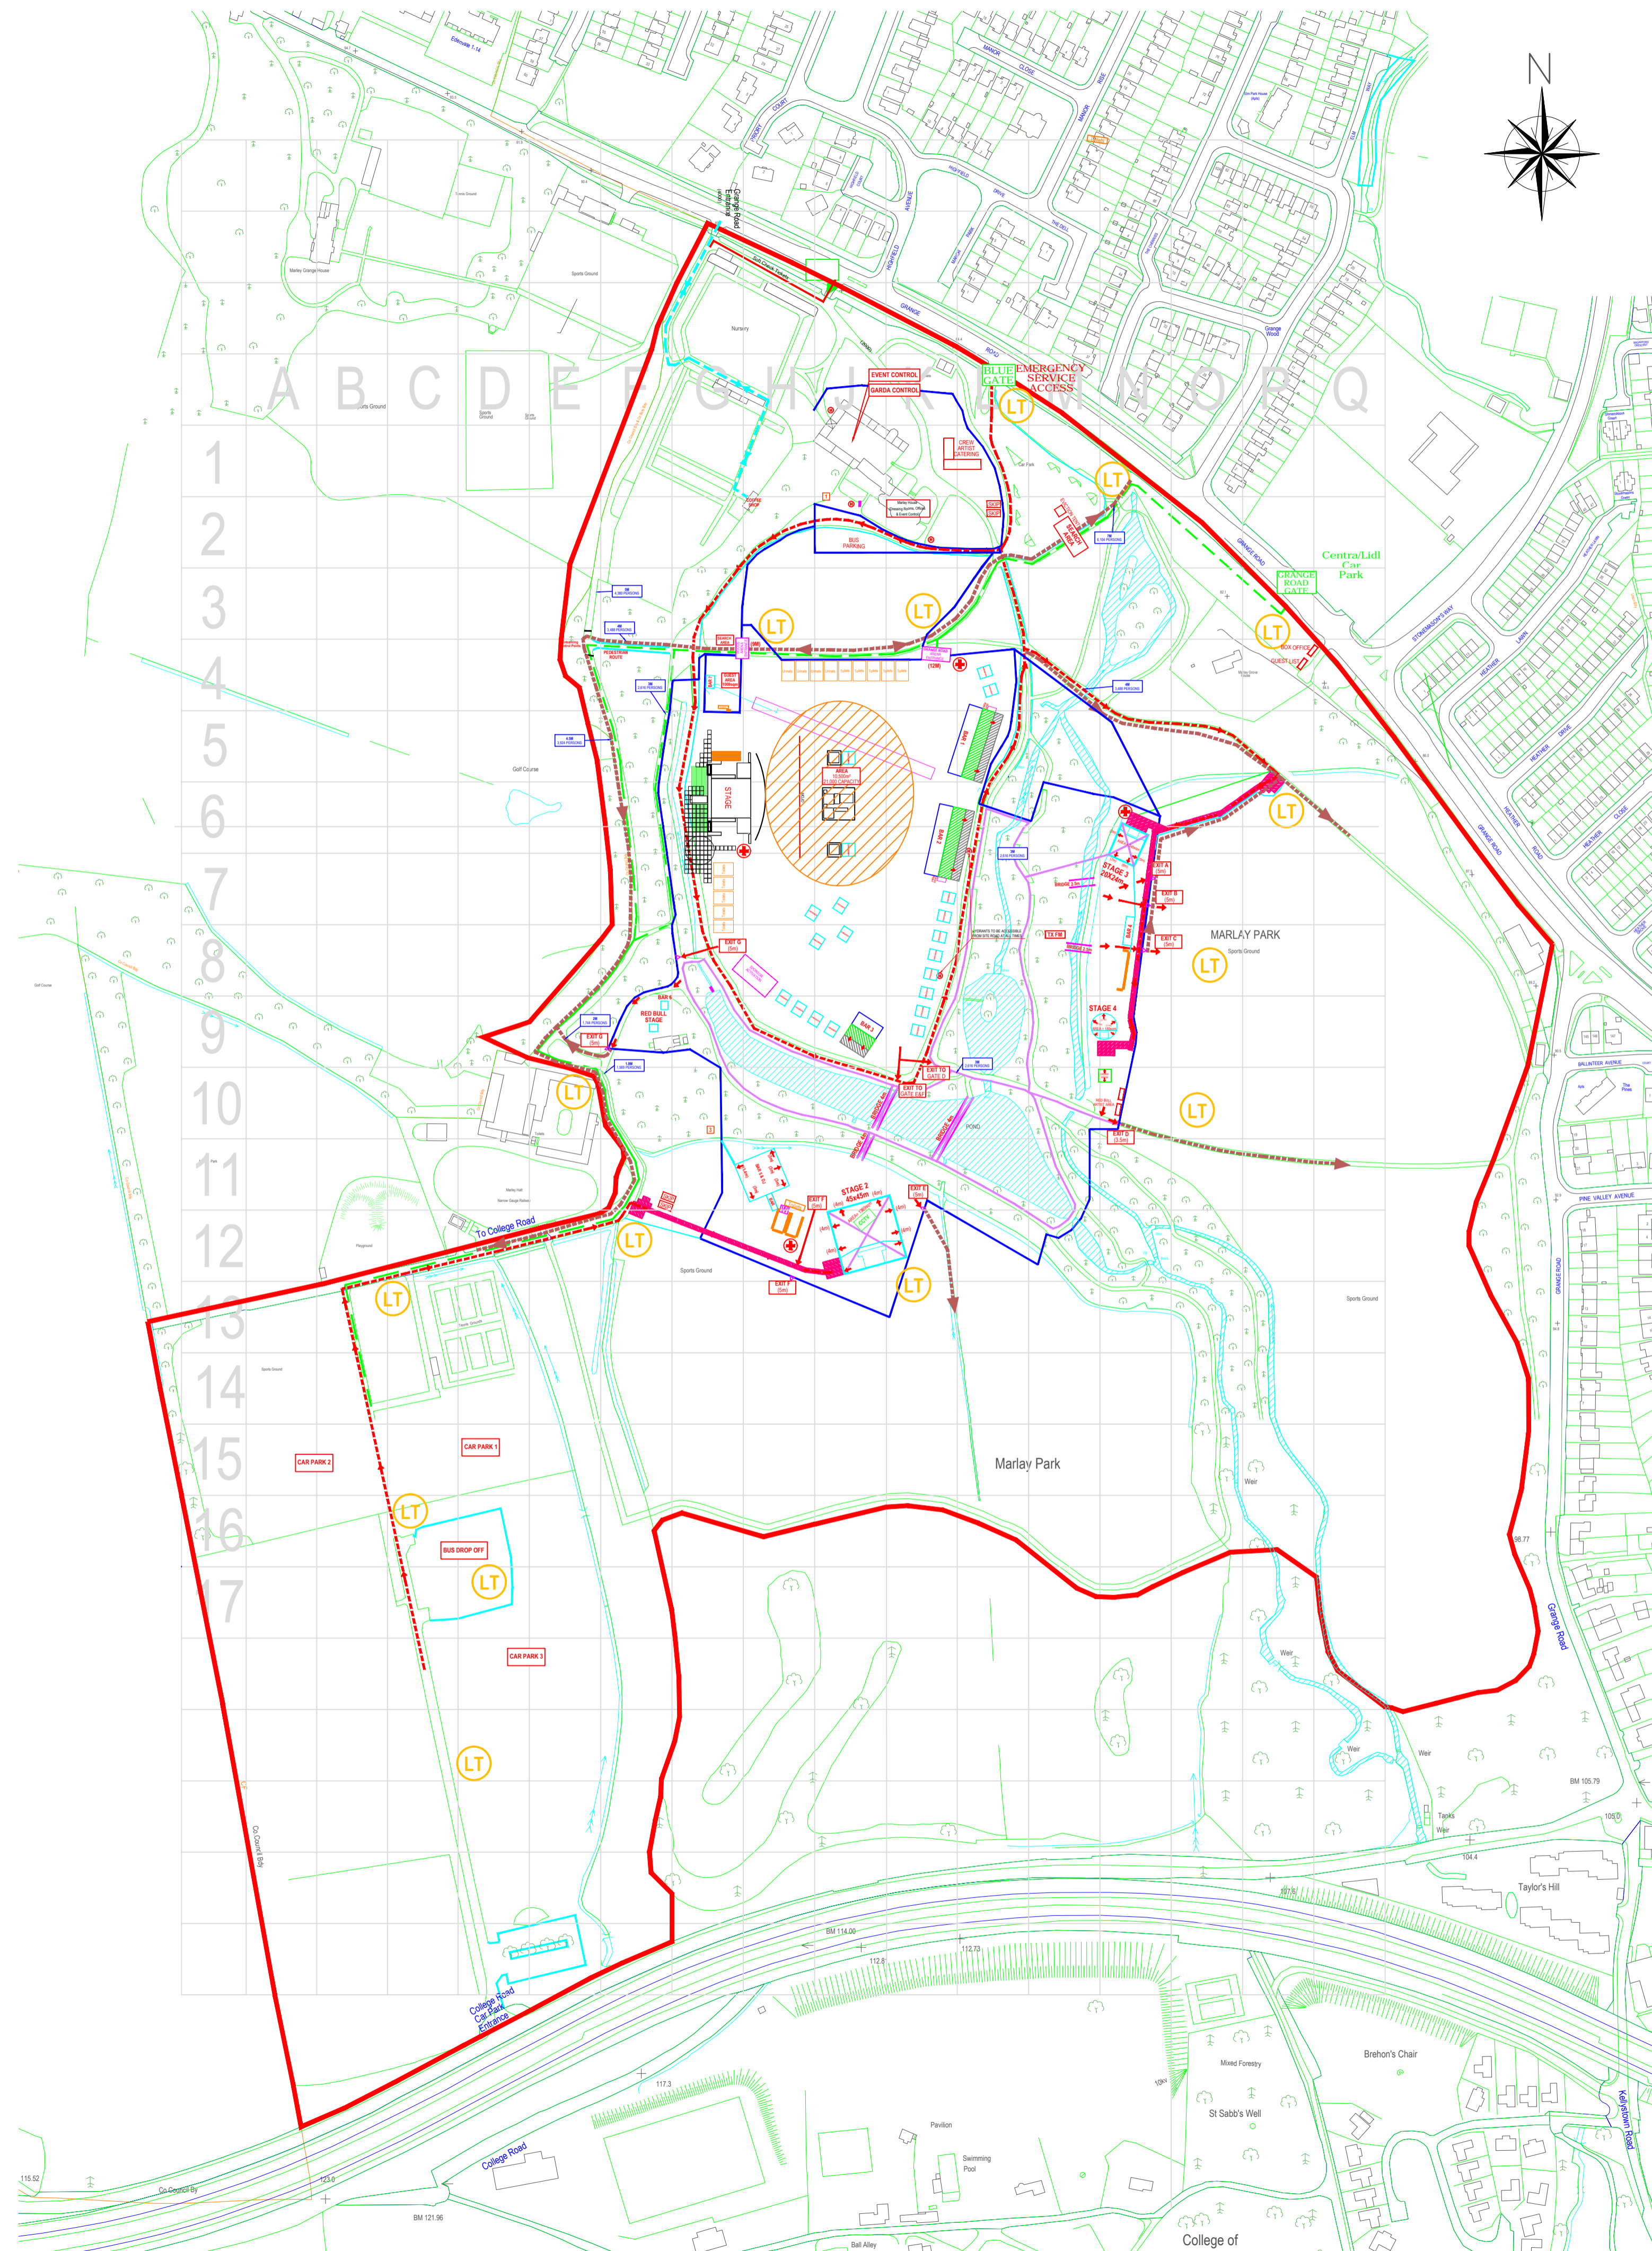

KEY:

Emerg. Rt / Site Road	Steelshield Fence	Heras Fence	Stage Sighting
Toilet Block	Concession	First Aid Post	CCTV Camera
Emergency Exit Route	Drinking Water	Fire Hydrant	Water Pipe
Pedestrian Route	Floodlights (indicative)	Festoon Lit Walkway	Route and Park Exit
Trackway Panels Are 3m Wide And Are Suitable For Carrying a 16.25 Tonne Fire Appliance.	Water	Entrance Route	

SITE BOUNDARY  
 Access to and from the coffee shop will be via the Walled Nursery Garden via the Grange Road.

KEY CONTACTS  
 Licence Compliance - Ange Goliger Tel: 086 0295820  
 Fire Safety Officer - David Slattery Tel: 087 9437787  
 Fire Safety Officer - Adrian Sutton Tel: 086 3940225

SCALE 1:2500 (@ A1)  
 DRAWING BY  
 RICHARD WHITE  
 FOR  
 MELVIN BENN AND FESTIVAL REPUBLIC

CONTACT: MELVIN BENN  
 THE FESTIVAL OFFICE  
 BORD GAIS ENERGY THEATRE  
 GRAND CANAL SQUARE  
 DOCKLANDS, DUBLIN 2  
 TEL (01) 6742476  
 GRIDLINES 50M x 50M

REV	DESCRIPTION	DATE

**Michael Slattery Associates**  
 Fire Safety Engineers

19 Windsor Place  
 Lower Pembroke Place  
 Dublin 2, Ireland  
 Tel: +353(1)6765713  
 Fax: +353(1)6785247


> Building Design & Construction  
 > Fire Engineering Design  
 > Event Safety & Management  
 > Building Fire Safety Management  
 > Disabled Access Consultancy  
 > Computer Modelling

PROJECT: LONGITUDE 2015  
 MARLAY PARK

TITLE: SITE LOCATION


SCALE: 1:2500 @ A1    JOB NO: 15110  
 DATE: 13.04.2015    DWG NO: 15110-02  
 CHECKED BY:    REV:



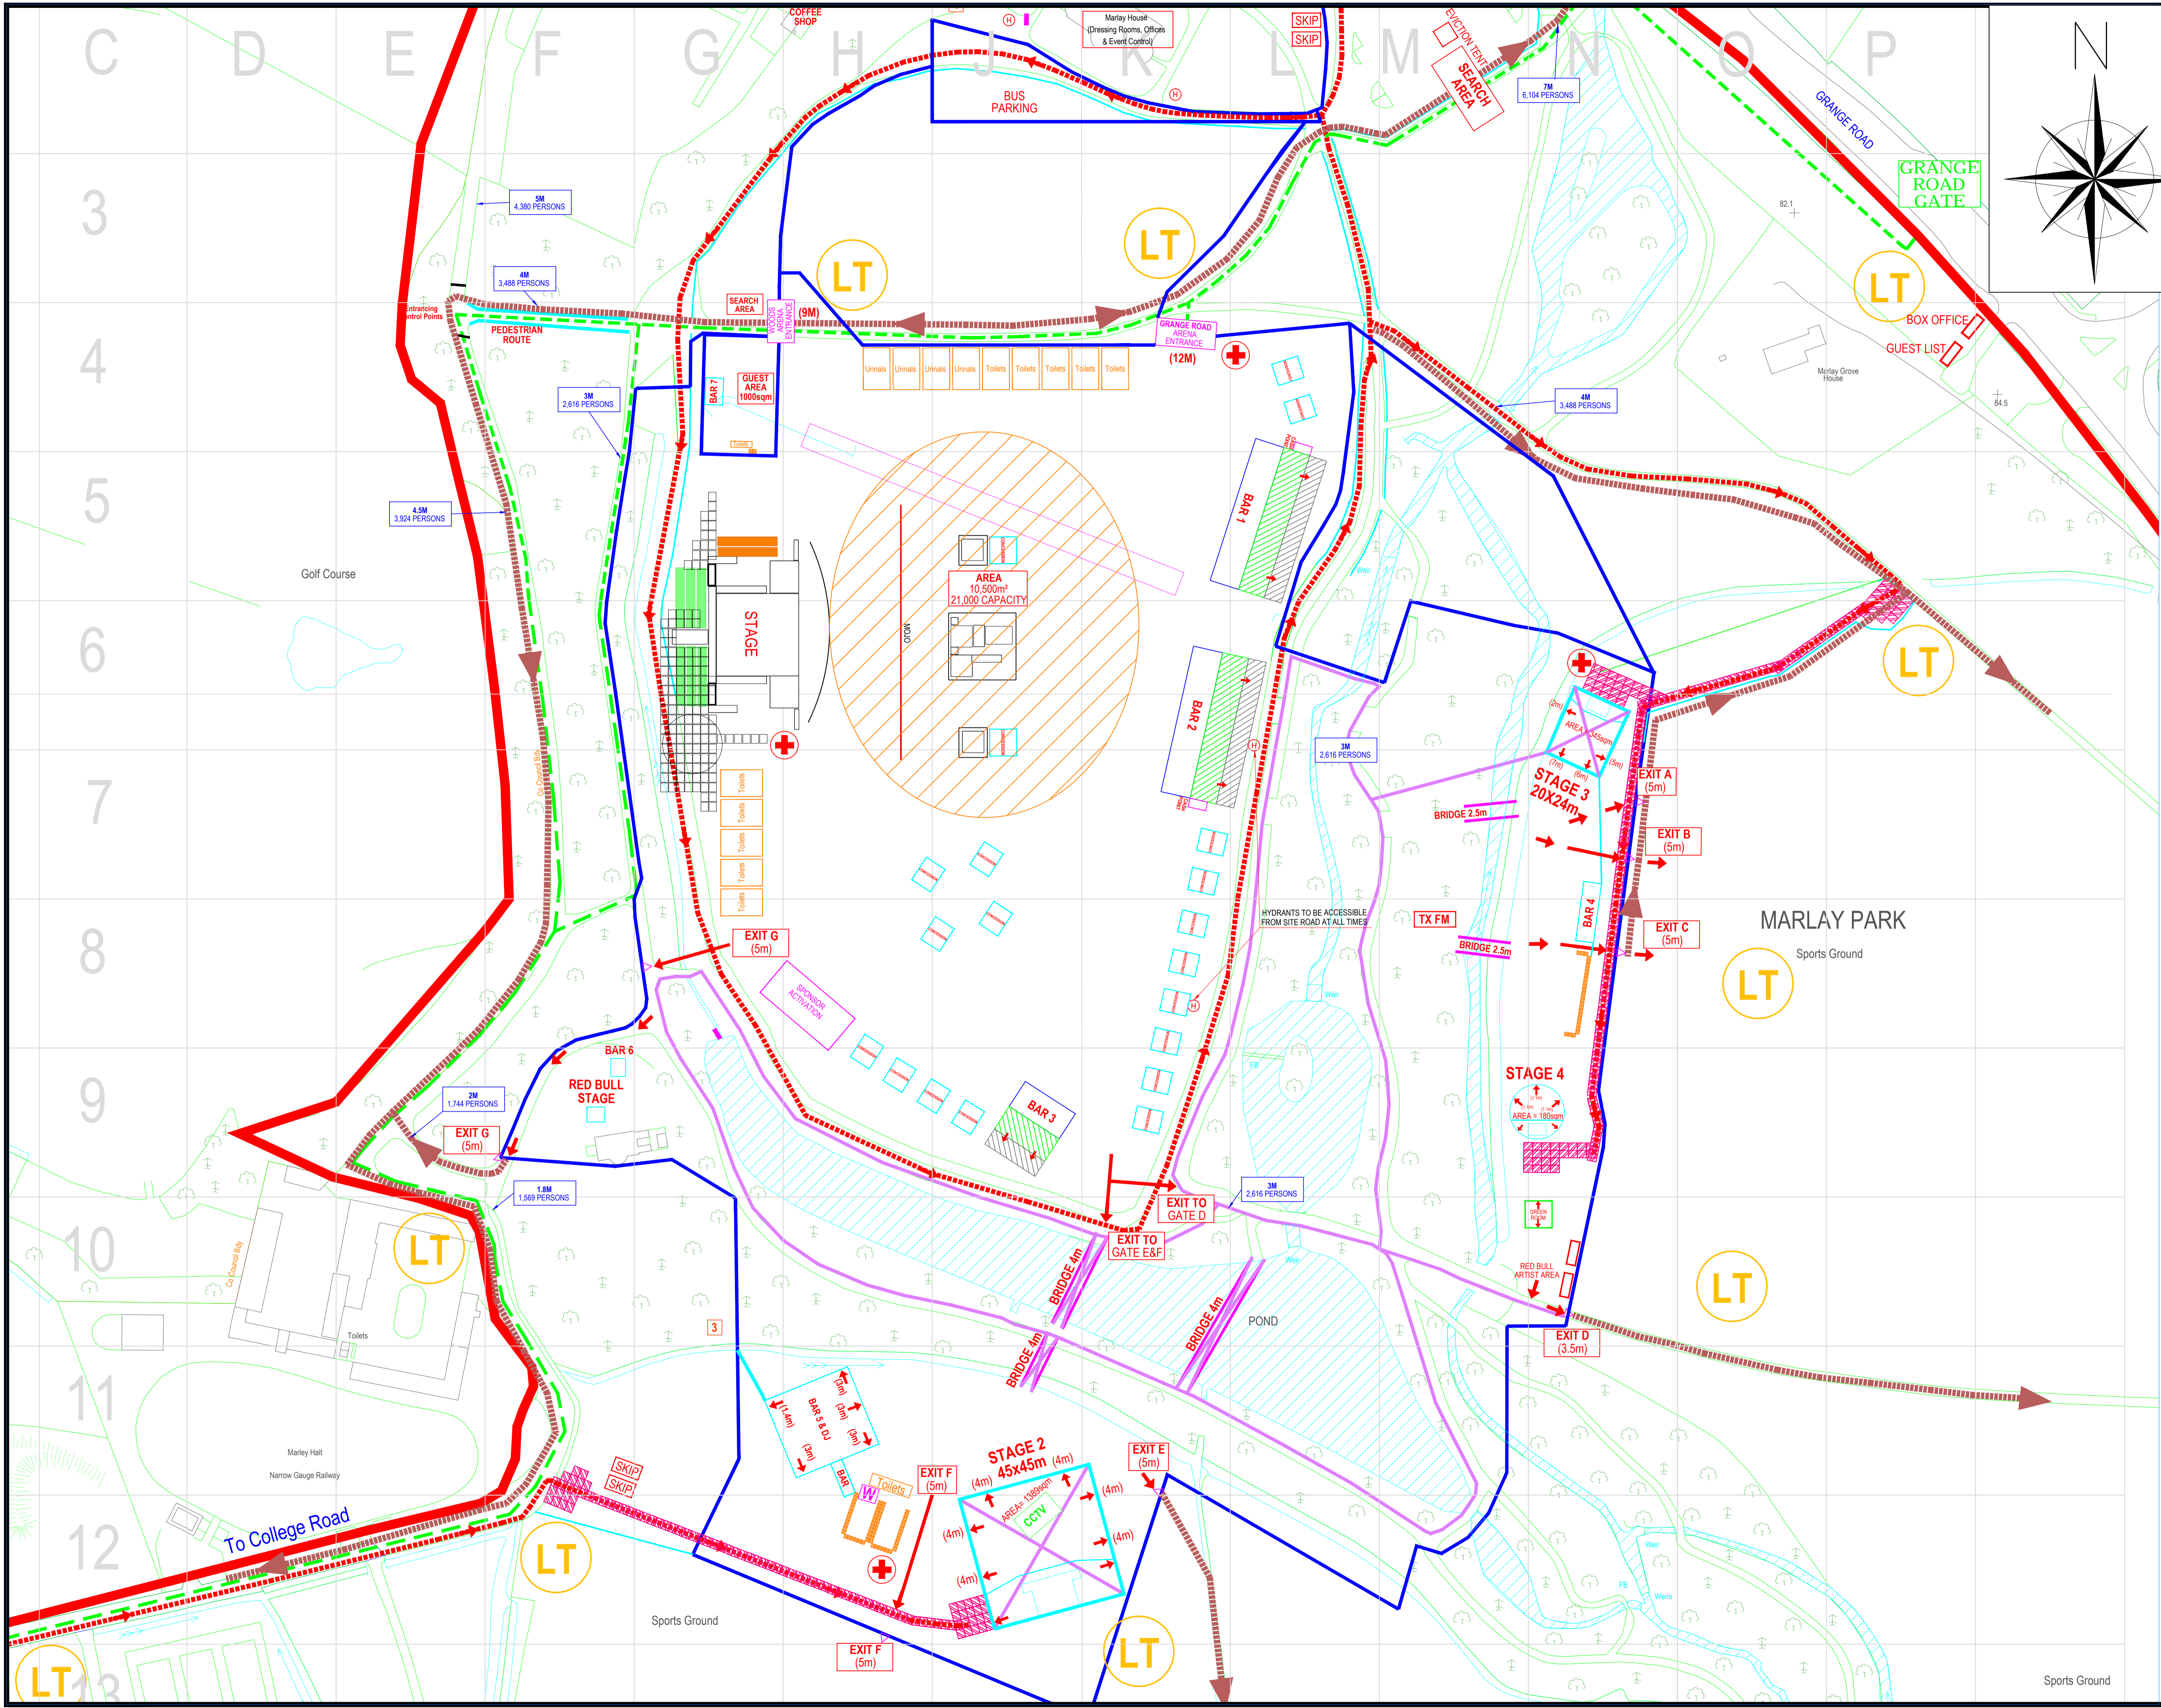

**KEY:**

Emerg. RI / Site Road	Steelhead Fence	Horse Fence	Stage Sighting
Toilet Block	Concession	First Aid Post	CCTV Camera
Emerging Exit Route	Drinking Water	Fire Hydrant	Water Pipe
Pedestrian Route	Floodlights (Indicative)	Festoon Lit Walkway	Route and Plank Exit
Trackway Panels Are 3m Wide And App Suitable For Carrying a 16.25 Tonne Fire Appliance	Water	Entrance Route	

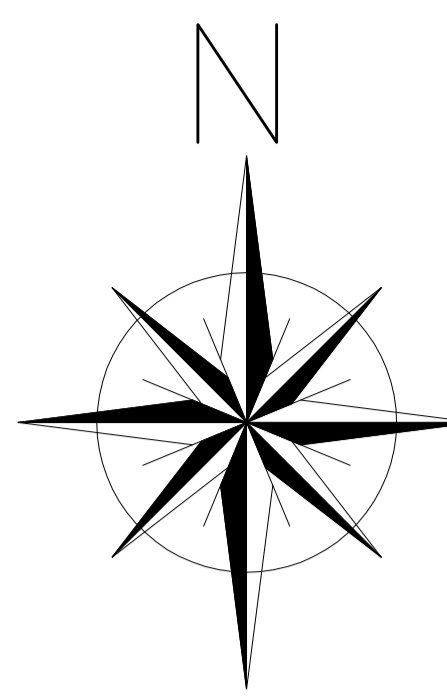

**SITE BOUNDARY**  
 Access to and from the coffee shop will be via the Walled Nursery Garden via the Grange Road.

**KEY CONTACTS**  
 Licence Compliance - Ange Goliger Tel: 086 0295820  
 Fire Safety Officer - David Slattery Tel: 087 9437787  
 Fire Safety Officer - Adrian Sutton Tel: 086 3940225

SCALE 1:1000 (@ A1)  
 DRAWING BY  
 RICHARD WHITE  
 FOR  
 MELVIN BENN AND FESTIVAL REPUBLIC  
 CONTACT: MELVIN BENN  
 THE FESTIVAL OFFICE  
 BORD GAIS ENERGY THEATRE  
 GRAND CANAL SQUARE  
 DOCKLANDS, DUBLIN 2  
 TEL (01) 6742476  
 GRIDLINES 50M x 50M

REV.	DESCRIPTION	DATE

**MSA**  
 Michael Slattery Associates  
 Fire Safety Engineers

PROJECT: LONGITUDE 2015 MARLAY PARK  
 TITLE: ARENA  
 SCALE: 1:1000 @ A1  
 DATE: 13.04.2015  
 CHECKED BY: [ ]  
 DRAWN BY: [ ]  
 DATE: [ ]  
 REV: [ ]