


KEY:

Emerg RT / Site Road	Shielded Fence	Hera Fence	Stage Sighting
Toilet Block	Concession	First Aid Post	CCTV Camera
Emergency Exit Route	Drinking Water	Fire Hydrant	Water Pipe
Pedestrian Route	Floodlights (Indicative)	Festoon LT Walkway	Route and Park Exit
Trackway Panels Are 3m Wide And Are Suitable For Carrying a 16.25 Tonne Fire Appliance.	Water	Entrance Route	Generator
			GEN

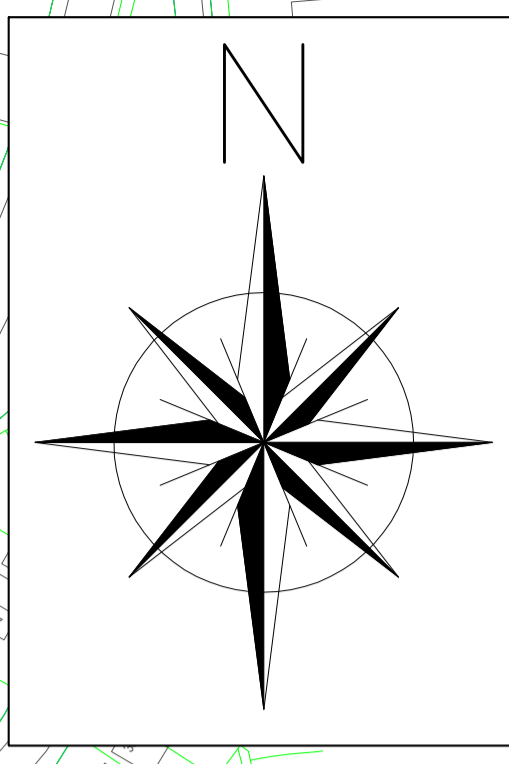

— SITE BOUNDARY
 - - - - Access to and from the coffee shop will be via the Walled Nursery Garden via the Grange Road.

KEY CONTACTS
 Event Controller - John Probyn Tel: +44 (0) 7595 676116
 Deputy Event Controller - Ange Golliger
 Tel: +353 (0) 86 0295820
 Event Safety - Ian Donaldson Tel: +44 (0) 7900 928796
 Fire Safety Officer - David Slattery Tel: 087 9437787
 Fire Safety Officer - Adrian Sutton Tel: 086 3940225

DRAFT

SCALE 1:1500 (@ A1)
 DRAWING BY
 RICHARD WHITE
 FOR
 MELVIN BENN AND FESTIVAL REPUBLIC

CONTACT: MELVIN BENN
 THE FESTIVAL OFFICE
 BORD GAIS ENERGY THEATRE
 GRAND CANAL SQUARE
 DOCKLANDS, DUBLIN 2

TEL (01) 6742476
 GRIDLINES 50M X 50M

Rev.	Description	DATE

MSA
 Michael Slattery Associates
 Fire Safety Engineers

125 Windsor Place
 Lower Pembroke Place
 Dublin 2, Ireland
 Tel: +353 (0) 7657 713
 Fax: +353 (0) 7657 547

Building Design & Construction
 Fire Engineering
 Event Safety & Management
 Building Site Safety Management
 Disabled Access Consultancy
 Computer Modelling

PROJECT: LONGITUDE 2017
 MARLAY PARK

TITLE: SITE PLAN

SCALE: 1:1500 @ A1 JOB No: 17069
 DATE: 30.03.2017 DWG No: 17069-01
 CHECKED BY: Rev